


Kit. Television in south wall
 is 29" (stud) from west wall w/o sheetrock
 cable/110v

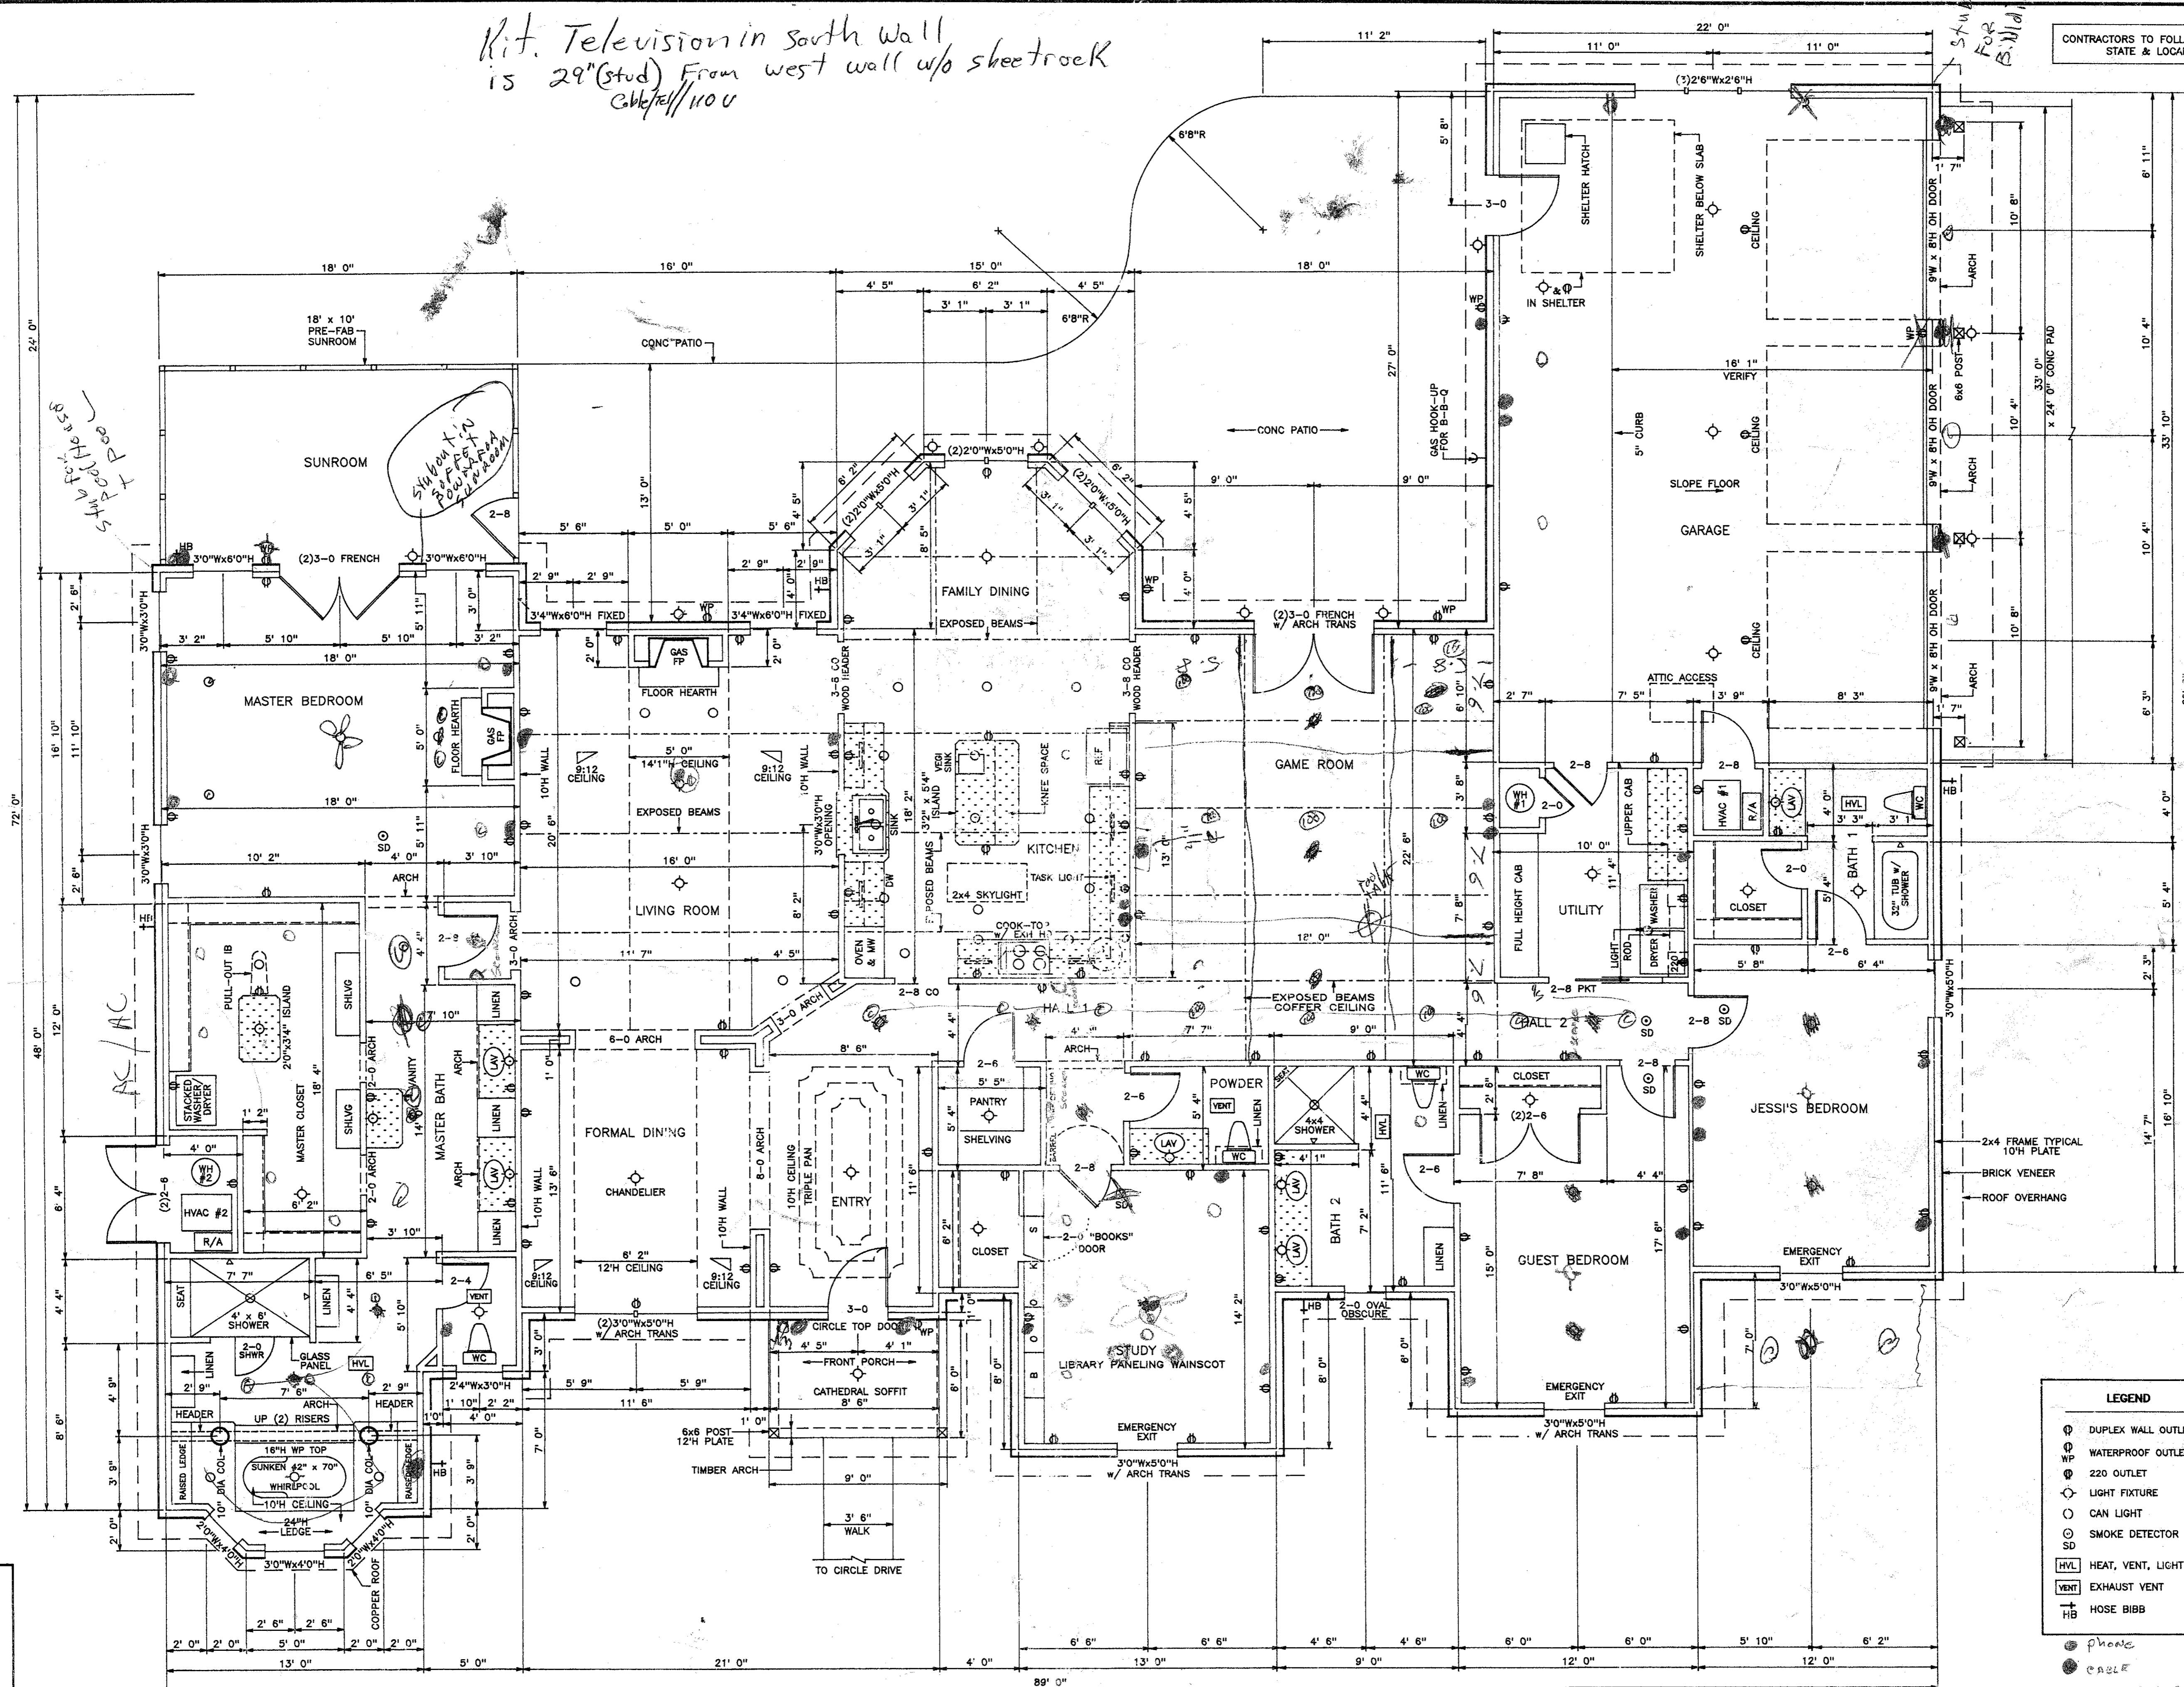


CONTRACTORS TO FOLLOW ALL APPLICABLE STATE & LOCAL CODES.

REFERENCE No 02-114

DRAWN BY
STEVE CARTRELL
 (918) 337-2266
 BARTLESVILLE, OK.

THE CC COMPANY, INC.
 513 CHESTNUT HILL BARTLESVILLE, OKLAHOMA 918/335-0592

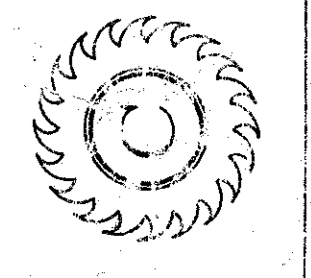

A RESIDENCE FOR
JERRY & TERRY LESCH
 BARTLESVILLE, OKLAHOMA

DATE
 MAY 9, 2002
 SHEET
1
 OF 2

SQUARE FEET	
TO FRAME LINE	
LIVING AREA	3400
SUNROOM	180
TOTAL	3580
GARAGE:	744

FLOOR PLAN
 SCALE: 1/4" = 1' 0"

LEGEND	
	DUPLEX WALL OUTLET
	WATERPROOF OUTLET
	220 OUTLET
	LIGHT FIXTURE
	CAN LIGHT
	SMOKE DETECTOR
	HV/L HEAT, VENT, LIGHT
	VENT EXHAUST VENT
	HB HOSE BIBB
	phone
	cable
	OUTSIDE LIGHTING
	SCONCE LIGHT FIXTURE