


*Kit. Tele. Rec. + Cable/tek
Stud = 29" From west
wall w/o sheet rock*

CONTRACTORS TO FOLLOW ALL APPLICABLE
STATE & LOCAL CODES.

REFERENCE No. 02-114

DRAWN BY
STEVE CANTRELL
(918) 337-2218
BARTLESVILLE, OK.

THE CC COMPANY, INC.
5773 CHESTNUT HILL BARTLESVILLE, OKLAHOMA 918/338-0592

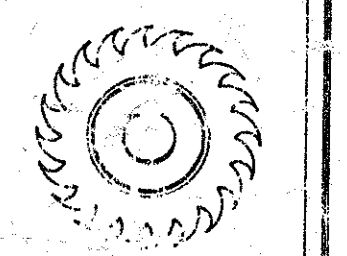


A RESIDENCE FOR
JERRY & TERRY LESCH
BARTLESVILLE, OKLAHOMA

DATE
MAY 9, 2002

SHEET
1

OF 2

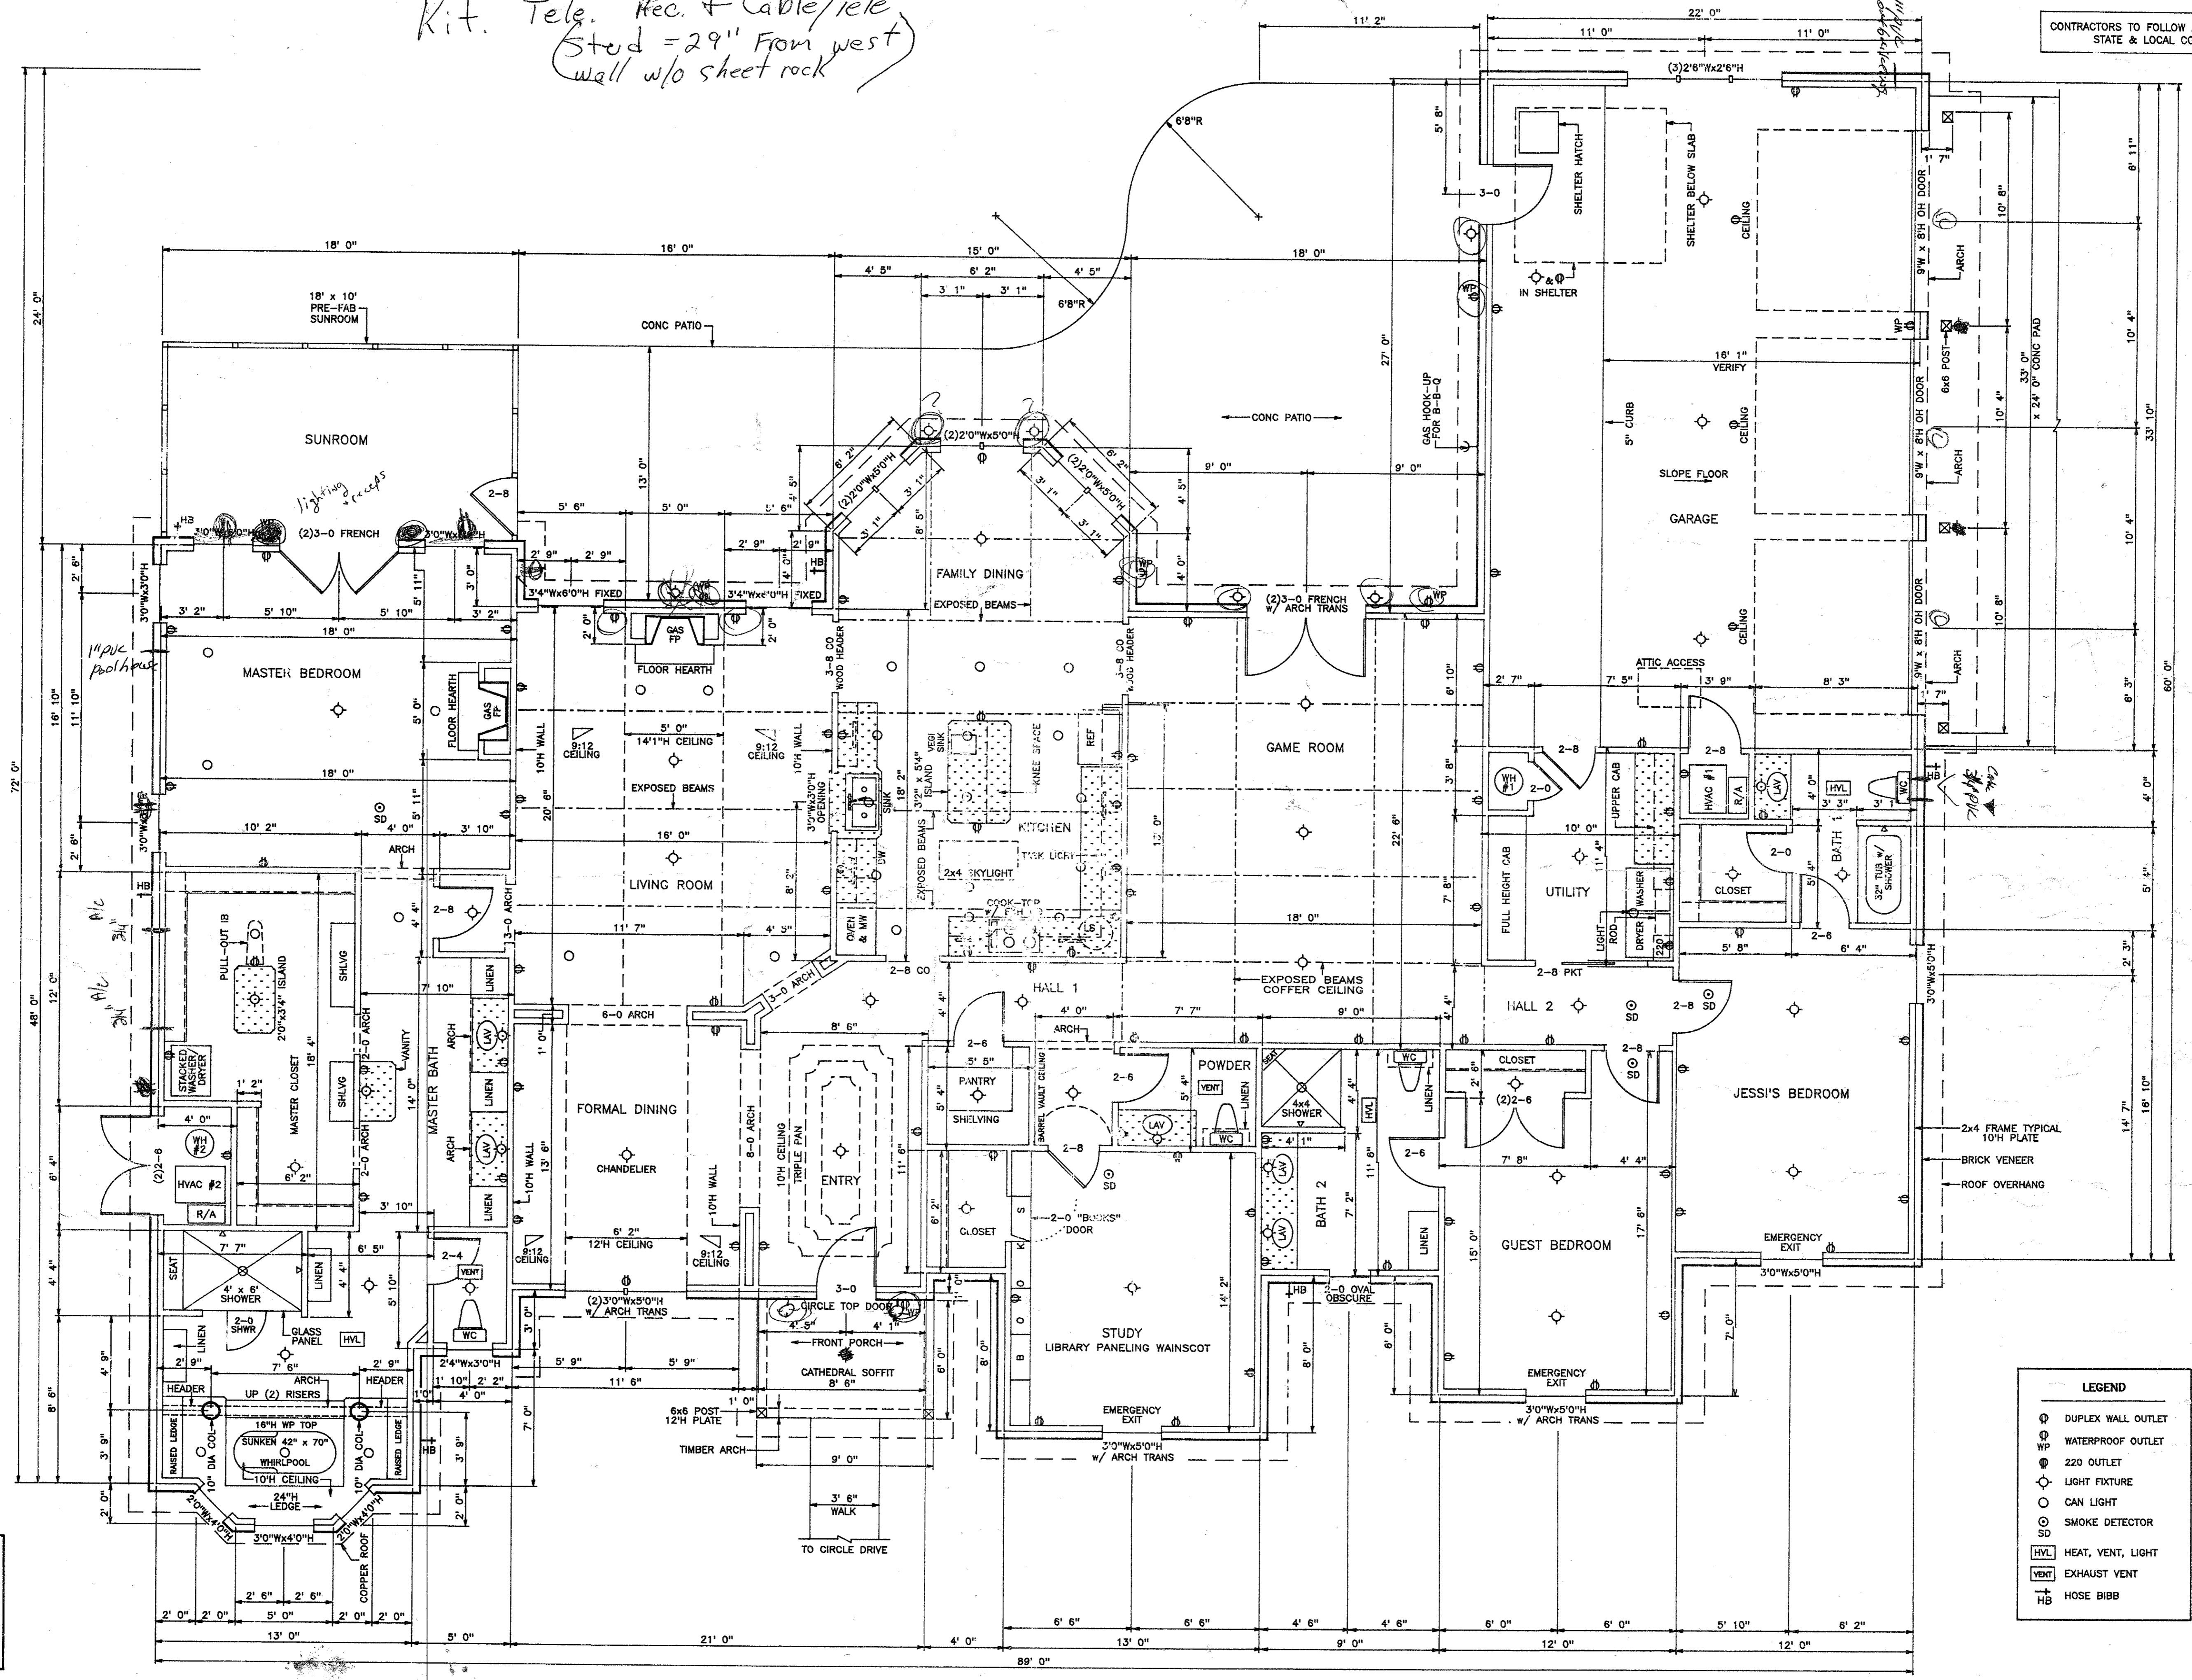

SQUARE FEET	
TO FRAME LINE	
LIVING AREA	3400
SUNROOM	180
TOTAL	3580
GARAGE:	744

LEGEND	
	DUPLEX WALL OUTLET
	WATERPROOF OUTLET
	220 OUTLET
	LIGHT FIXTURE
	CAN LIGHT
	SMOKE DETECTOR
	HEAT, VENT, LIGHT
	EXHAUST VENT
	HOSE BIBB

FLOOR PLAN
SCALE: 1/4" = 1' 0"